


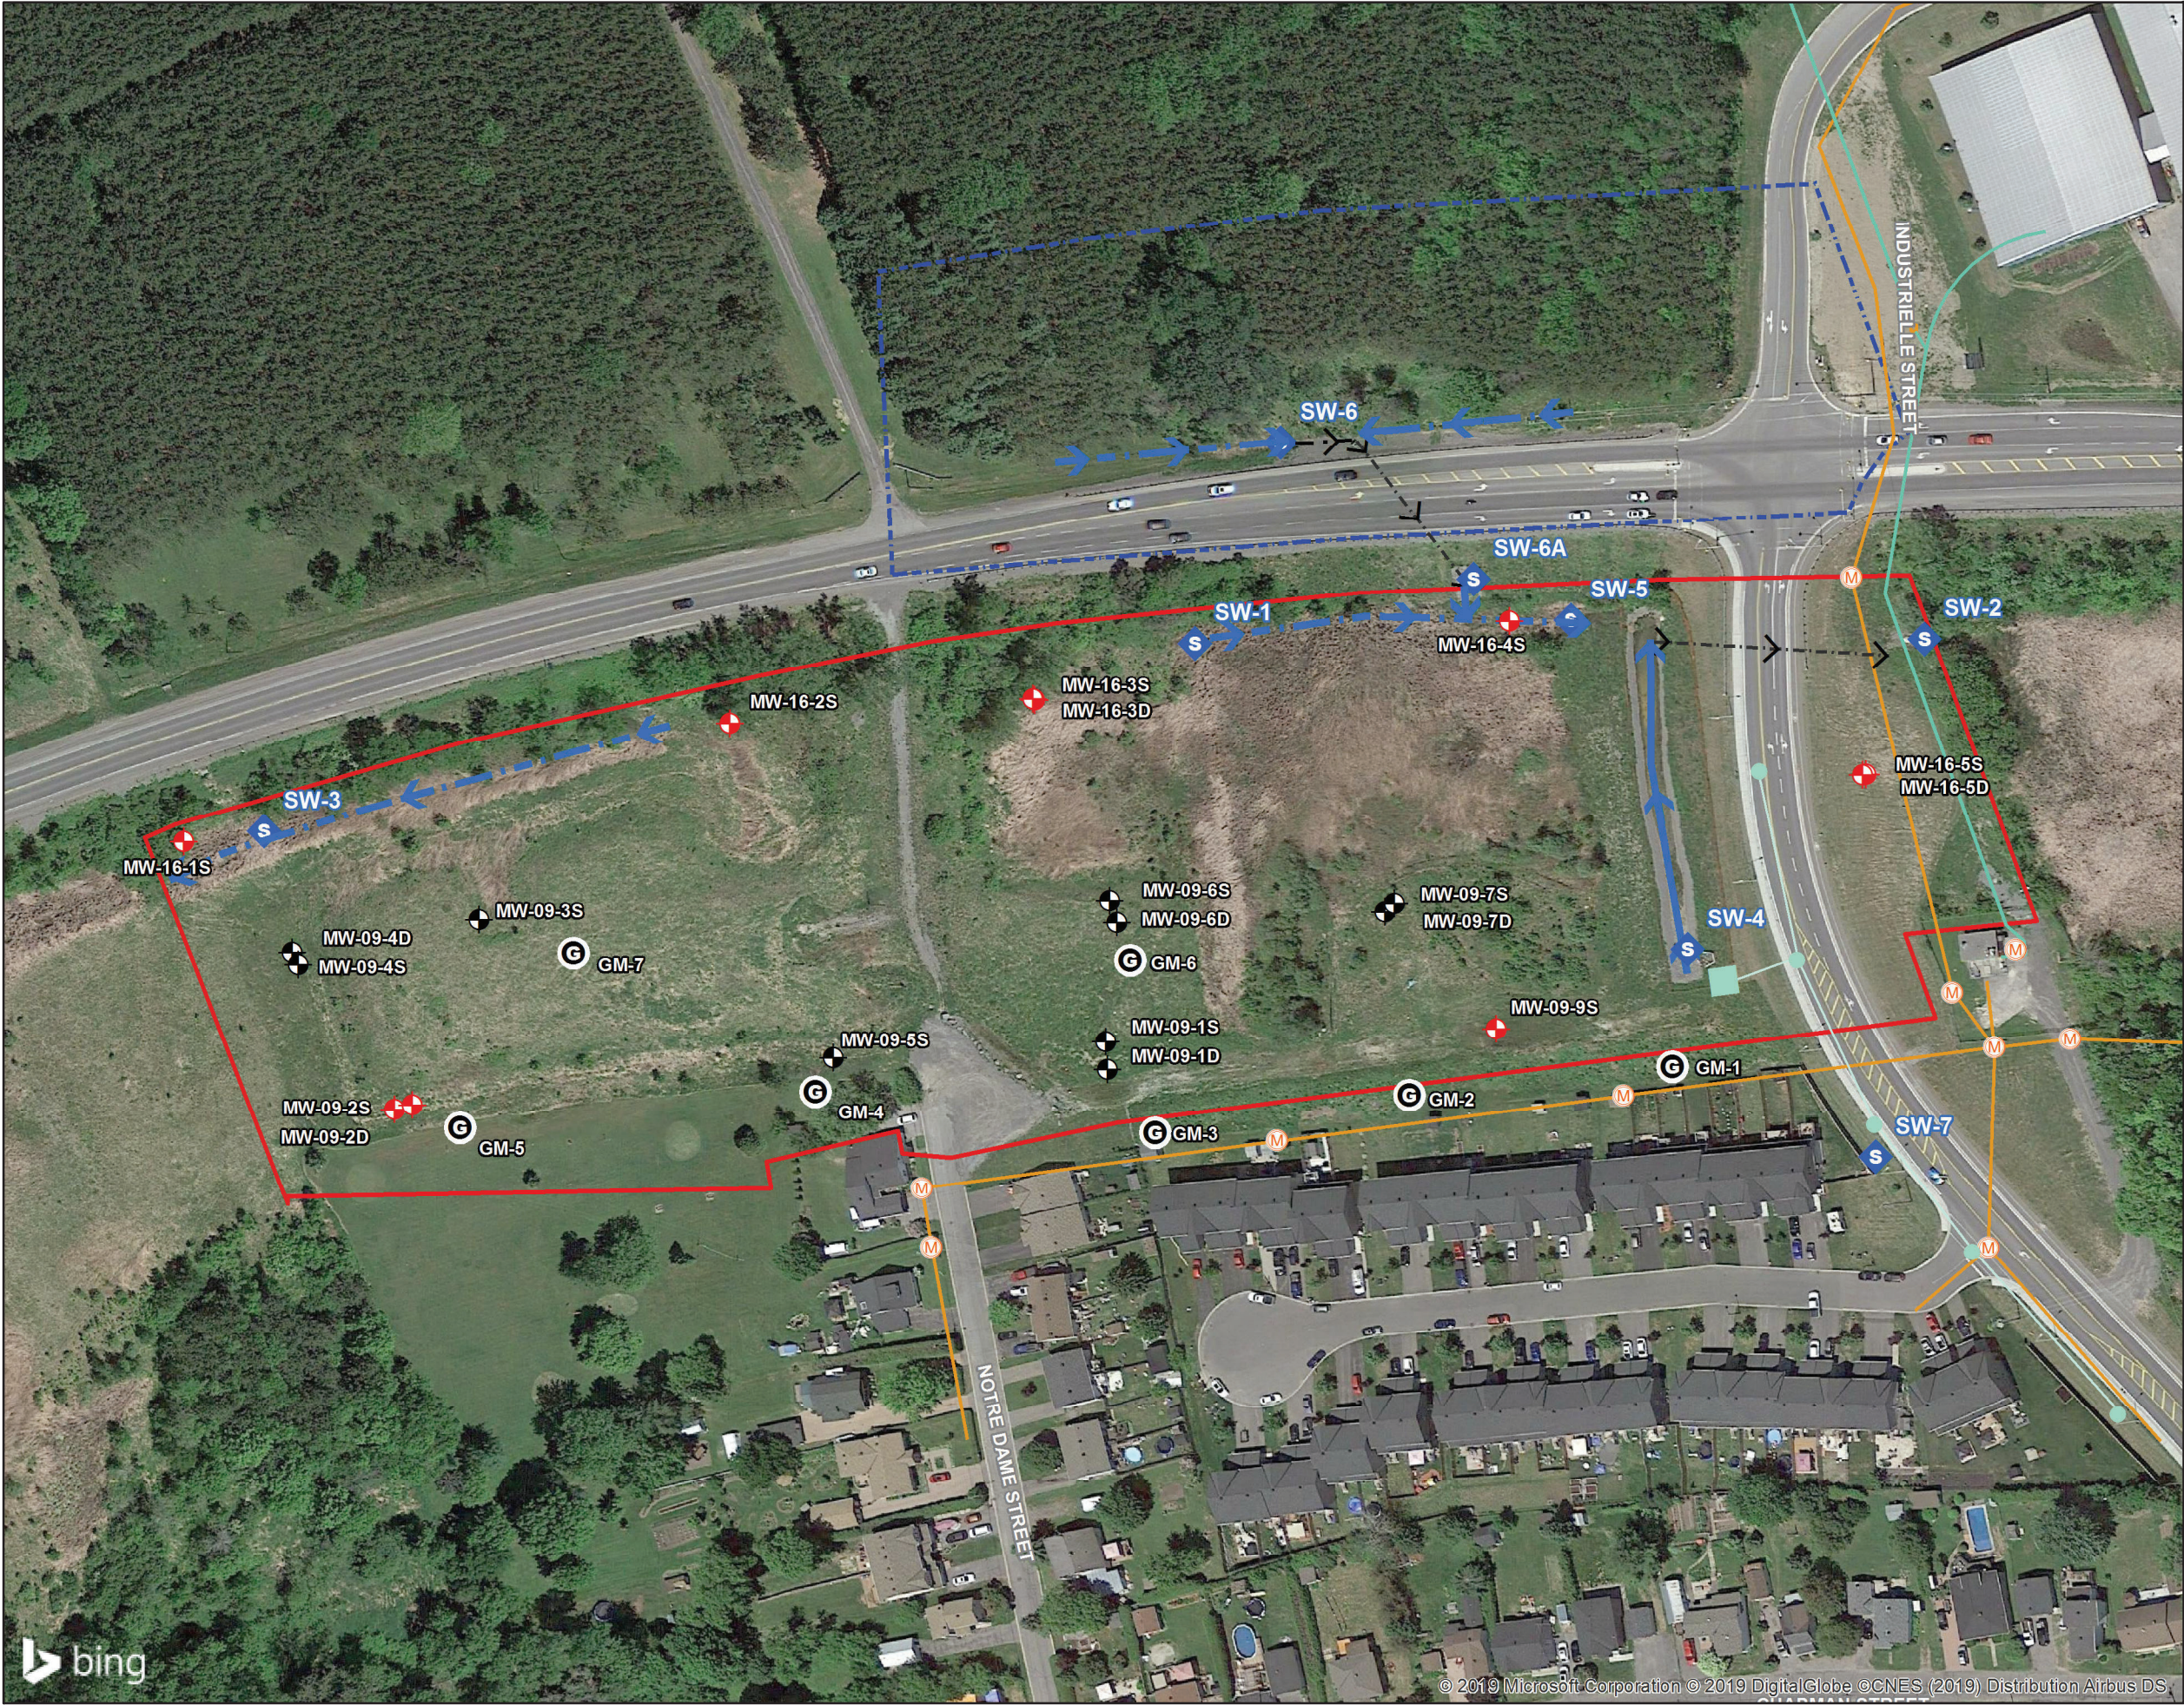

1345 ROSEMOUNT AVENUE
CORNWALL, ONTARIO
CANADA K6J 3E5
PHONE: 613-933-5602 FAX: 613-936-0335
WWW.WSPGROUP.COM

CLIENT: CITY OF ROCKLAND

PROJECT: CARON STREET LANDFILL
2018 FALL SURFACE WATER
ASSESSMENT

LEGEND

- PROPERTY LINES
- SITE BOUNDARY
- SURFACE WATER MONITORING LOCATION
- INTERMITTENT SURFACE WATER CHANNEL FLOW DIRECTION
- STORMWATER CHANNEL AND FLOW DIRECTION
- CULVERT AND FLOW DIRECTION
- GROUNDWATER MONITORING WELL
- GROUNDWATER MONITORING WELL
- DRAINAGE AREA TO COUNTY RD 17 CULVERT
- MANHOLE (SANITARY)
- MANHOLE (STORM)
- STORMWATER DISCHARGE INLET
- CARON STREET
- SANITARY SEWAGE NETWORK
- SANITARY SEWAGE FORCE MAIN
- STORM SEWER NETWORK
- STORMWATER DISCHARGE OUTLET

 
PROJECT NUMBER:
151-10915-00

DATE:
FEBRUARY 2019

DRAWN BY: GR

CHECKED BY: ST

SCALE: 1:1,500



NAD1983 ZONE 18

SITE PLAN

FIGURE NUMBER:
FIG. 8

